



DRAWING LIST

SHEET NO.	DWG. NO.	DRAWING DESCRIPTION
01	CV	COVER SHEET
02	GN	NOTES, LEGEND AND ABBREVIATIONS AND UTILITY LIST
03	IN	SANITARY SEWER INDEX MAP & DRAWING LIST
04	RHR-1	SANITARY SEWER PLAN & PROFILE - RED HILL ROAD
05	RHR-2	SANITARY SEWER PLAN & PROFILE - RED HILL ROAD
06	RHR-3	SANITARY SEWER PLAN & PROFILE - RED HILL ROAD
07	RHR-4	SANITARY SEWER PLAN & PROFILE - RED HILL ROAD
08	RHR-5	SANITARY SEWER PLAN & PROFILE - RED HILL ROAD
09	CR	SANITARY SEWER PLAN & PROFILE - CHURCH ROAD
10	WSR	SANITARY SEWER PLAN & PROFILE - WEST SHORTCUT ROAD
11	JP-N	SANITARY SEWER PLAN & PROFILE - JUNIATA PARKWAY NORTH
12	JP-S1	SANITARY SEWER PLAN & PROFILE - JUNIATA PARKWAY SOUTH
13	JP-S2	LOW PRESSURE SANITARY SEWER PLAN & PROFILE - JUNIATA PARKWAY SOUTH
14	JP-S3	LOW PRESSURE SANITARY SEWER PLAN & PROFILE - JUNIATA PARKWAY SOUTH
15	JP-S4	LOW PRESSURE SANITARY SEWER PLAN & PROFILE - JUNIATA PARKWAY SOUTH
16	RHR-6	LOW PRESSURE SANITARY SEWER PLAN & PROFILE - RED HILL ROAD
17	RHR-7	LOW PRESSURE SANITARY SEWER PLAN & PROFILE - RED HILL ROAD
18	CD	LOW PRESSURE SANITARY SEWER PLAN & PROFILE - CRAMER DRIVE
19	FM-1	SANITARY SEWER PLAN & PROFILE - JUNIATA PARKWAY PUMP STATION FORCE MAIN
20	FM-2	SANITARY SEWER PLAN & PROFILE - JUNIATA PARKWAY PUMP STATION FORCE MAIN
21	FM-3	SANITARY SEWER PLAN & PROFILE - JUNIATA PARKWAY PUMP STATION FORCE MAIN
22	FM-4	SANITARY SEWER PLAN & PROFILE - JUNIATA PARKWAY PUMP STATION FORCE MAIN
23	FM-5	SANITARY SEWER PLAN & PROFILE - WEST SHORTCUT ROAD PUMP STATION FORCE MAIN
24	FM-6	SANITARY SEWER PLAN & PROFILE - WEST SHORTCUT ROAD PUMP STATION FORCE MAIN
25	FM-7	SANITARY SEWER PLAN & PROFILE - WEST SHORTCUT ROAD PUMP STATION FORCE MAIN
26	FM-8	SANITARY SEWER PLAN & PROFILE - WEST SHORTCUT ROAD PUMP STATION FORCE MAIN
27	JRC	SANITARY SEWER PLAN & PROFILE - JUNIATA RIVER AND NORFOLK SOUTHERN R.R. CROSSING
28	SI-JP	SITE PLAN - JUNIATA PARKWAY PUMP STATION
29	SI-JP	PLAN AND CROSS SECTION - JUNIATA PARKWAY PUMP STATION
30	SI-WSR	SITE PLAN - WEST SHORTCUT ROAD PUMP STATION
31	SI-WSR	PLAN AND CROSS SECTION - WEST SHORTCUT ROAD PUMP STATION
32	SI-H	SITE PLAN - HOWE PUMP STATION
33	SI-H	PLAN AND CROSS SECTION - HOWE PUMP STATION
34	DT-1	MISCELLANEOUS CONSTRUCTION DETAILS
35	DT-2	MISCELLANEOUS CONSTRUCTION DETAILS
36	DT-3	MISCELLANEOUS CONSTRUCTION DETAILS
37	DT-4	MISCELLANEOUS CONSTRUCTION DETAILS
38	TY-1	PENNDOT TYPICAL SECTIONS

SANITARY SEWER INDEX MAP
SCALE: 1" = 500'

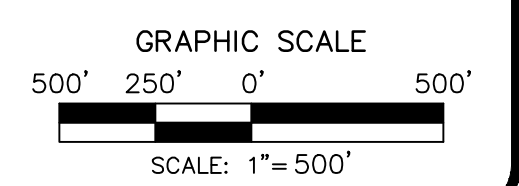

NO.	REVISION	DATE	BY

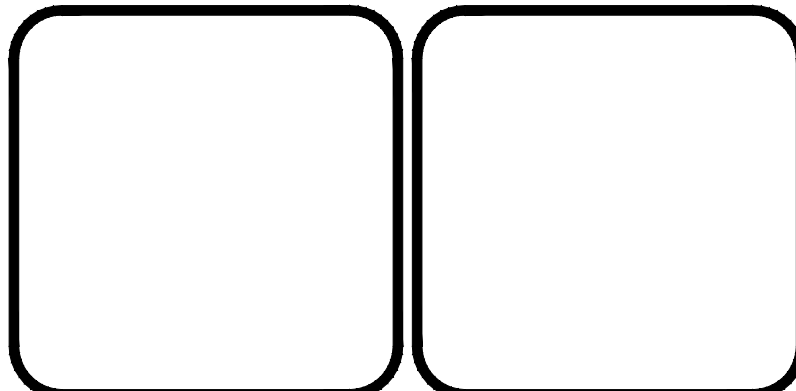

HRG
Herbert, Rowland & Grubic, Inc.
Engineering & Related Services
AN EMPLOYEE-OWNED COMPANY

369 East Park Drive
Harrisburg, PA 17111
(717) 564-1121
Fax (717) 564-1158
hrg@hrg-inc.com
www.hrg-inc.com

HOWE TOWNSHIP MUNICIPAL AUTHORITY
319 N. 4TH STREET
NEWPORT, PA 17074

SANITARY SEWER INDEX MAP & DRAWING LIST
FOR
HOWE TOWNSHIP SANITARY SEWER EXTENSION

HOWE TOWNSHIP PERRY COUNTY PENNSYLVANIA

PROJ. MGR. - JTF
DESIGN- JTF
CADD- RSF
CHECKED-
SCALE- AS NOTED
DATE- MAY 2015

DRAWING NO.
IN

SHEET NO.
3 OF 38

PROJECT 005100.0434